 

 = A/C condenser 884h x 820w x 315d
 within louvred housing
 1200w x 1000h x 450d

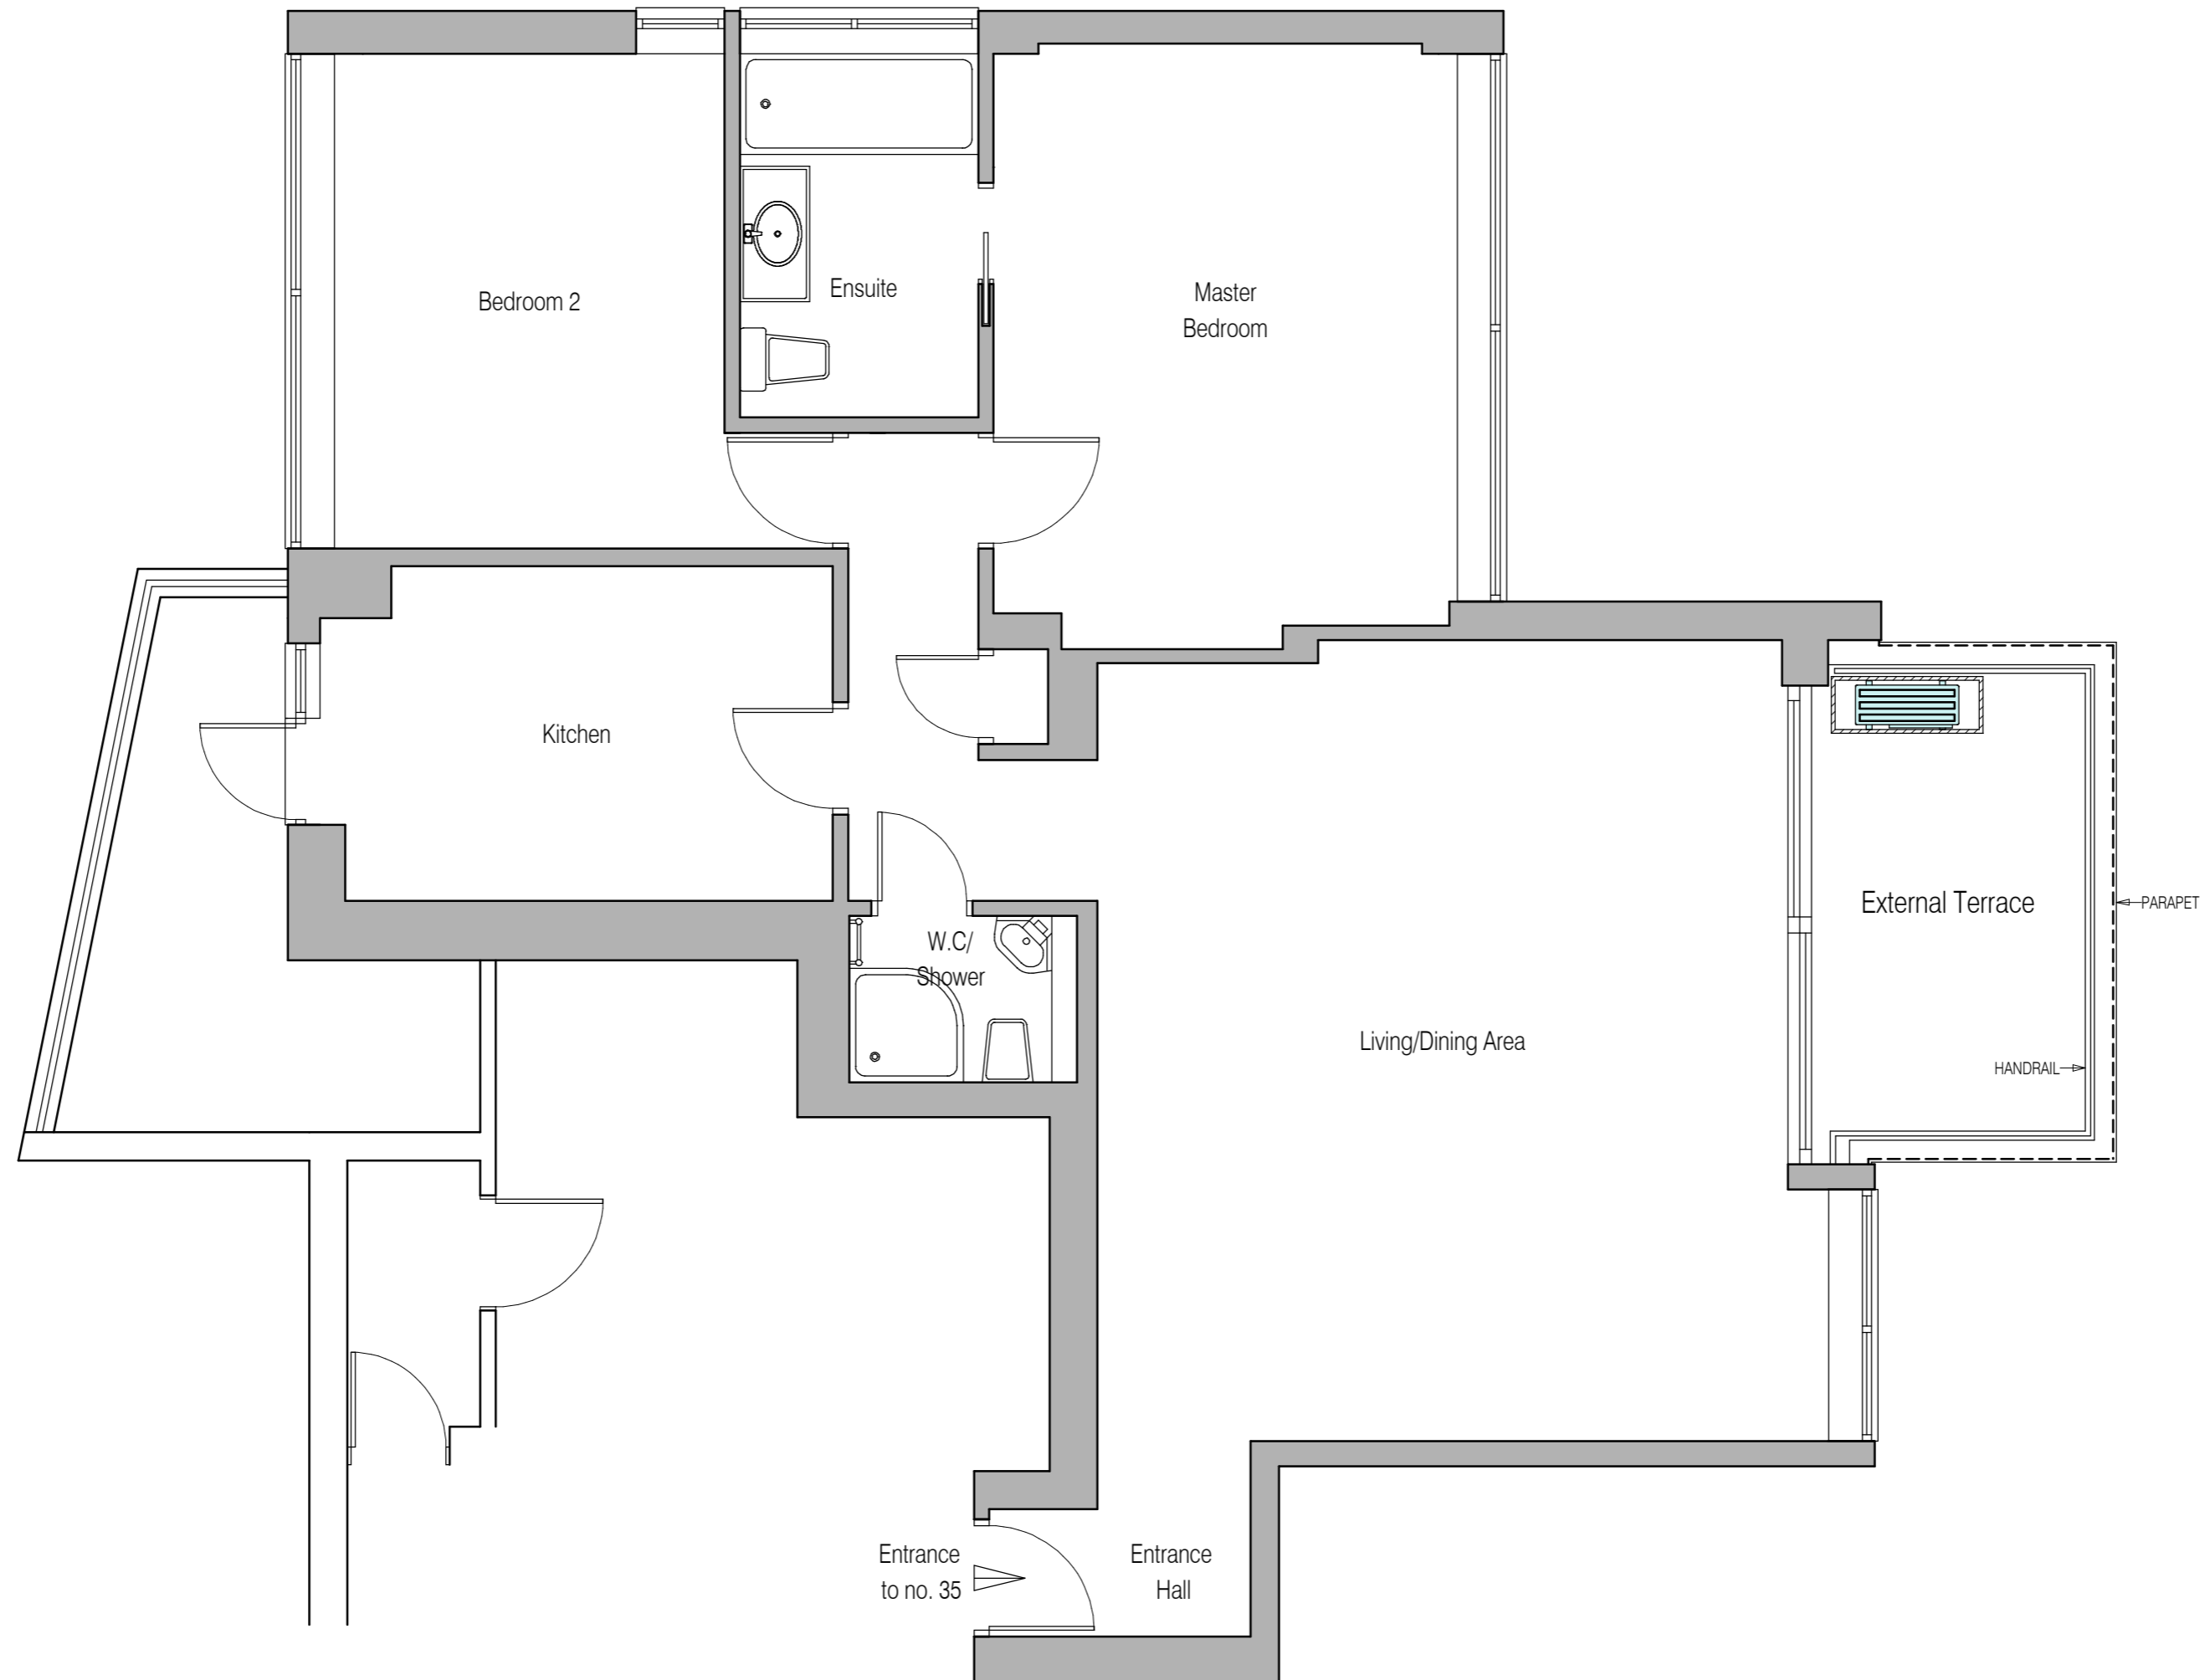

Date	Revision	Drawn
ADDRESS Flat 35 Imperial Court London NW8 7PT		A. P. Lester Design and surveying services 07973 867028 andylester@hotmail.co.uk apl.plans@gmail.com
PROJECT Proposed installation of air cooling system		SCALE 1:50 @ A2 1:100 @ A4
DRAWING TITLE Proposed A/C floor plan		DRAWN APL REV. DWC. NO. 35C/NW8/2 DATE AUG 2021
Copyright of A. P. Lester		