




Housing-Solutions

Better Homes by Design

07780 795121

housing-solutions@outlook.com

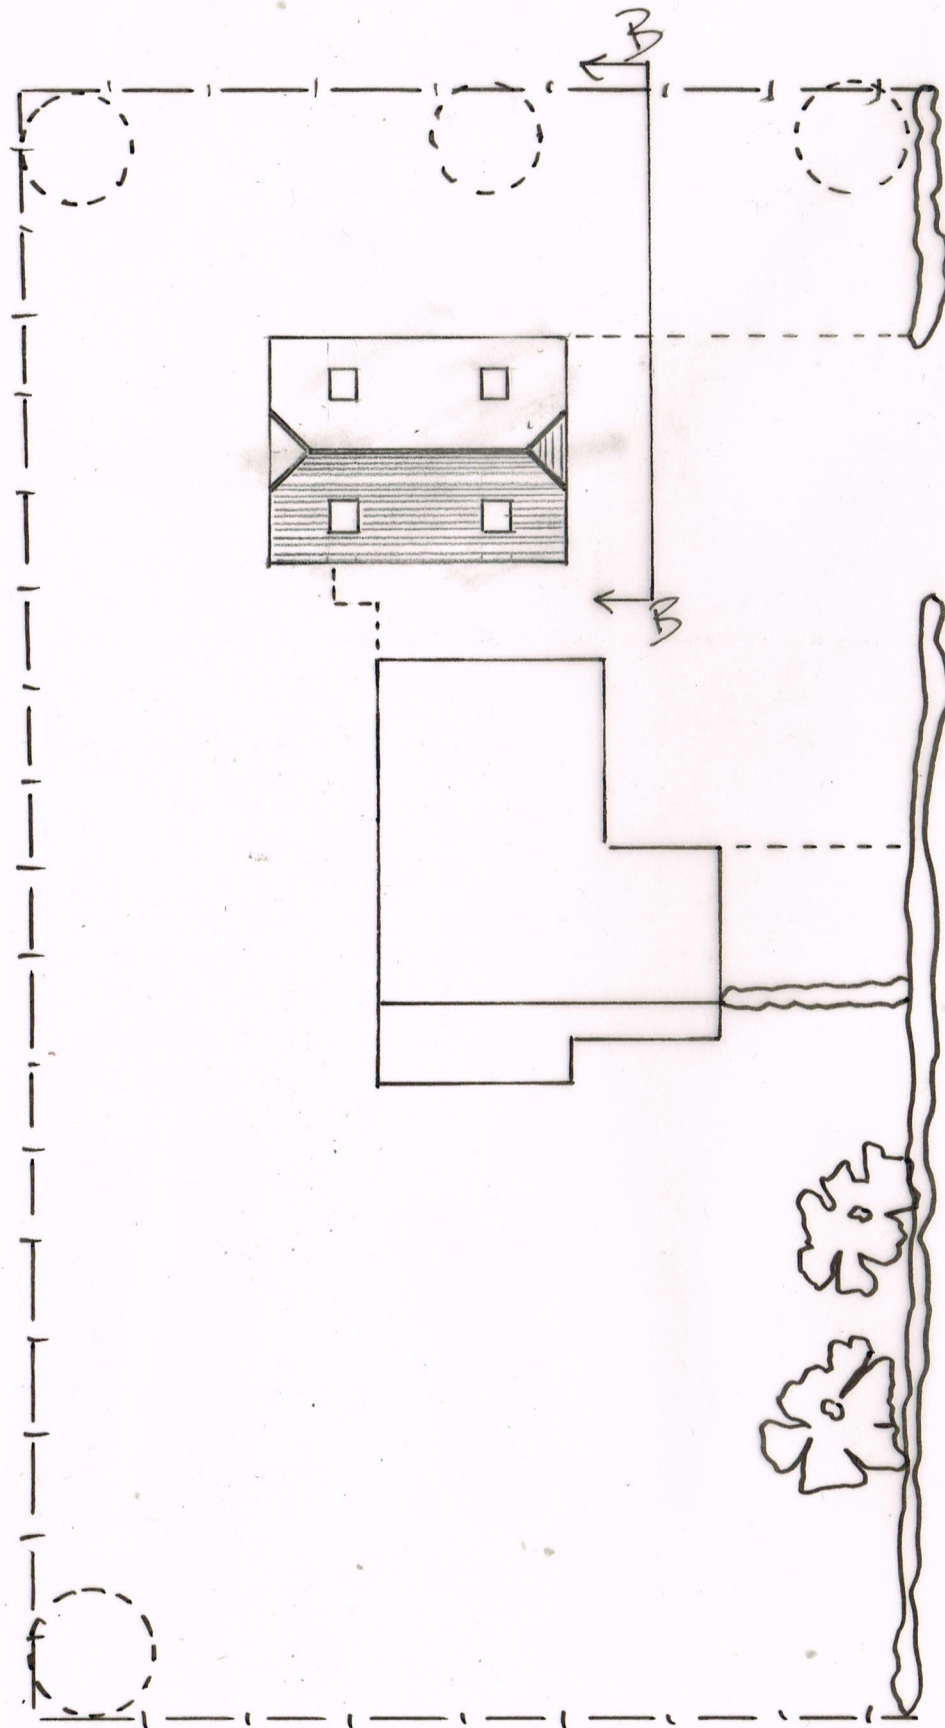

10m

SITE ADDRESS:	Oak Tree Cottage The Street, Ulcombe, Maidstone, ME17 1DP	CLIENT DETAILS:	Mr. Andrew Harris		
DRAWINGS:	Proposed Landscaping & Drainage Layout	DRAWN BY:	A BRILEY	REF:	OTC/0523/19006
DATE:	September 2023	SCALE:	1: 200 (A3)	REV:	B