


Note :
 The contractor will be held to have checked all dimensions before commencing with any works and in the event of discrepancies, is to refer them directly to this office for clarification prior to commencement of work.
 Written dimensions are to be taken in all cases. Drawings should not be scaled for dimensions. In case of doubt refer to this office.
 This drawing is copyright and all rights are reserved. No unauthorised copying of this drawing is permitted.


ELECTRICAL LEGEND

- MAIN MAIN SWITCHBOARD
- DB1 DISTRIBUTION BOARD
- ELECTRICITY METER
- SOCKET OUTLET (SWITCHED)
- 2 - TWIN SOCKET
- LL - LOW LEVEL (450mm AFFL)
- ML - MID LEVEL (1100mm AFFL)
- BL - BEDHEAD LEVEL (900mm AFFL)
- TVL - TV LEVEL (1700mm AFFL with 500mm flex)
- ULL - LOW LEVEL with USB (450mm AFFL)
- UML - MID LEVEL with USB (1100mm AFFL)
- UBL - BEDHEAD LEVEL with USB (900mm AFFL)

- SOCKET OUTLET (UNSWITCHED)
- FUSED CONNECTION UNIT (DOUBLE POLE SWITCHED)
- FUSED CONNECTION UNIT (UNSWITCHED)
- TWIN CAT 6 OUTLET
- COAXIAL TV OUTLET
- INTERNAL DOWNLIGHTER
- PENDANT CEILING LIGHT
- INTERNAL WALL LIGHT
- ONE WAY 6amp PLATESWITCH
- TWO WAY 6amp PLATESWITCH
- EXTERNAL DOWNLIGHTER
- EXTERNAL BULKHEAD LIGHT (LED)
- EXTERNAL UPLIGHTER (LED recessed)
- EXTERNAL LIGHTING POINT ON PIR
- SHAVER SOCKET
- SINGLE GANG 13 amp NEON SWITCH
- SATELITE TV SOCKET
- TELEPHONE/INTERNET SOCKET
- WATER SUPPLY
- LPG SUPPLY
- SMOKE DETECTOR
- HEAT DETECTOR
- CARBON DIOXIDE DETECTOR
- CARBON MONOXIDE DETECTOR
- MECHANICAL EXTRACT FAN
- COOKER CONNECTION UNIT
- 45amp D.P. SWITCH

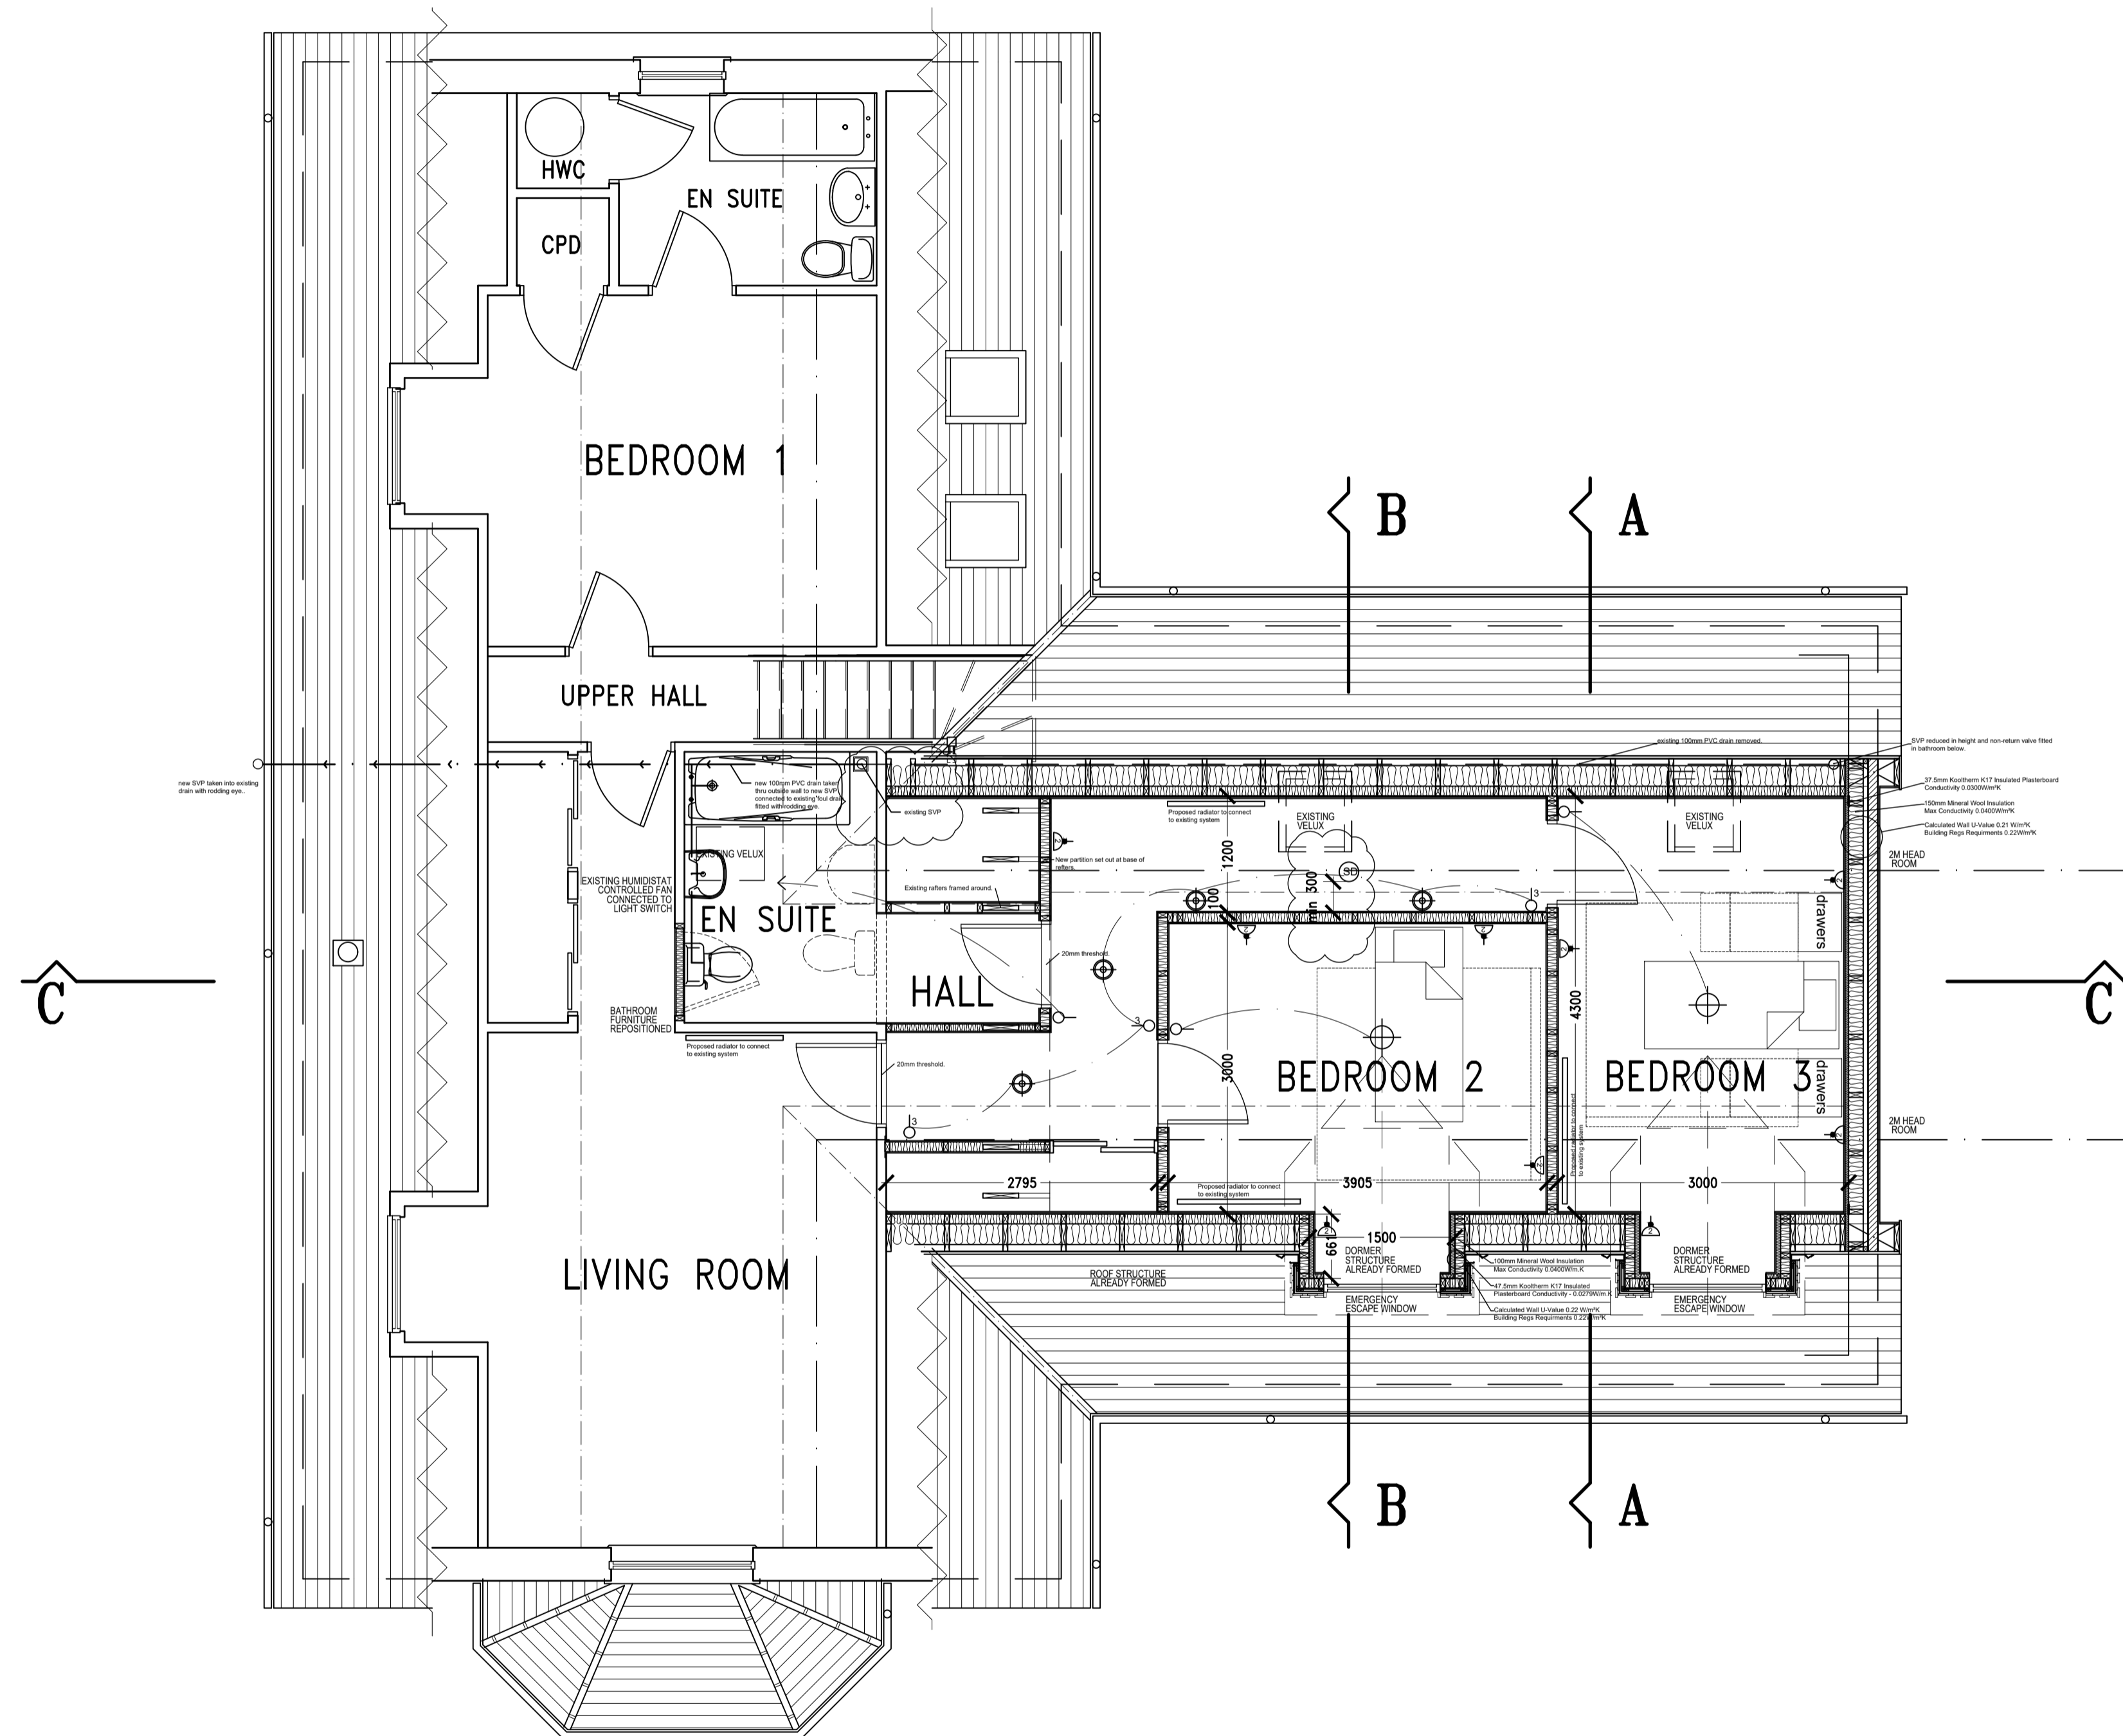

FIRST FLOOR PLAN

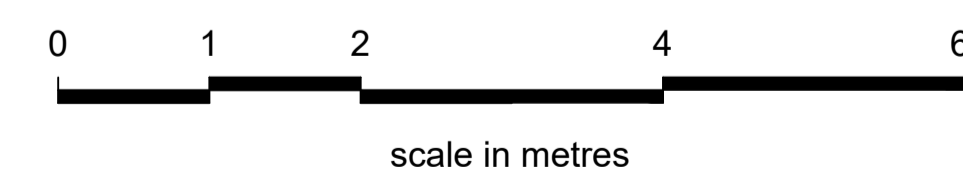

Project ATTIC CONVERSION OTTERBURN	
Client MR AND MRS BUNGEY	
Drawing FIRST FLOOR PLAN AS PROPOSED Use Class 9	
Scale 1:50 @A1	Date
Drawn	Checked
Drg. No. 0812016/A110 D	



kearney donald partnership
 chartered architects & planning supervisor

Hillside House • Belford Road
 Fort William • PH33 6BT
 Tel: 01397 704333
 Fax: 01397 704123
 E-mail: mail@kd-partnership.co.uk
 Web site: www.kd-partnership.co.uk